
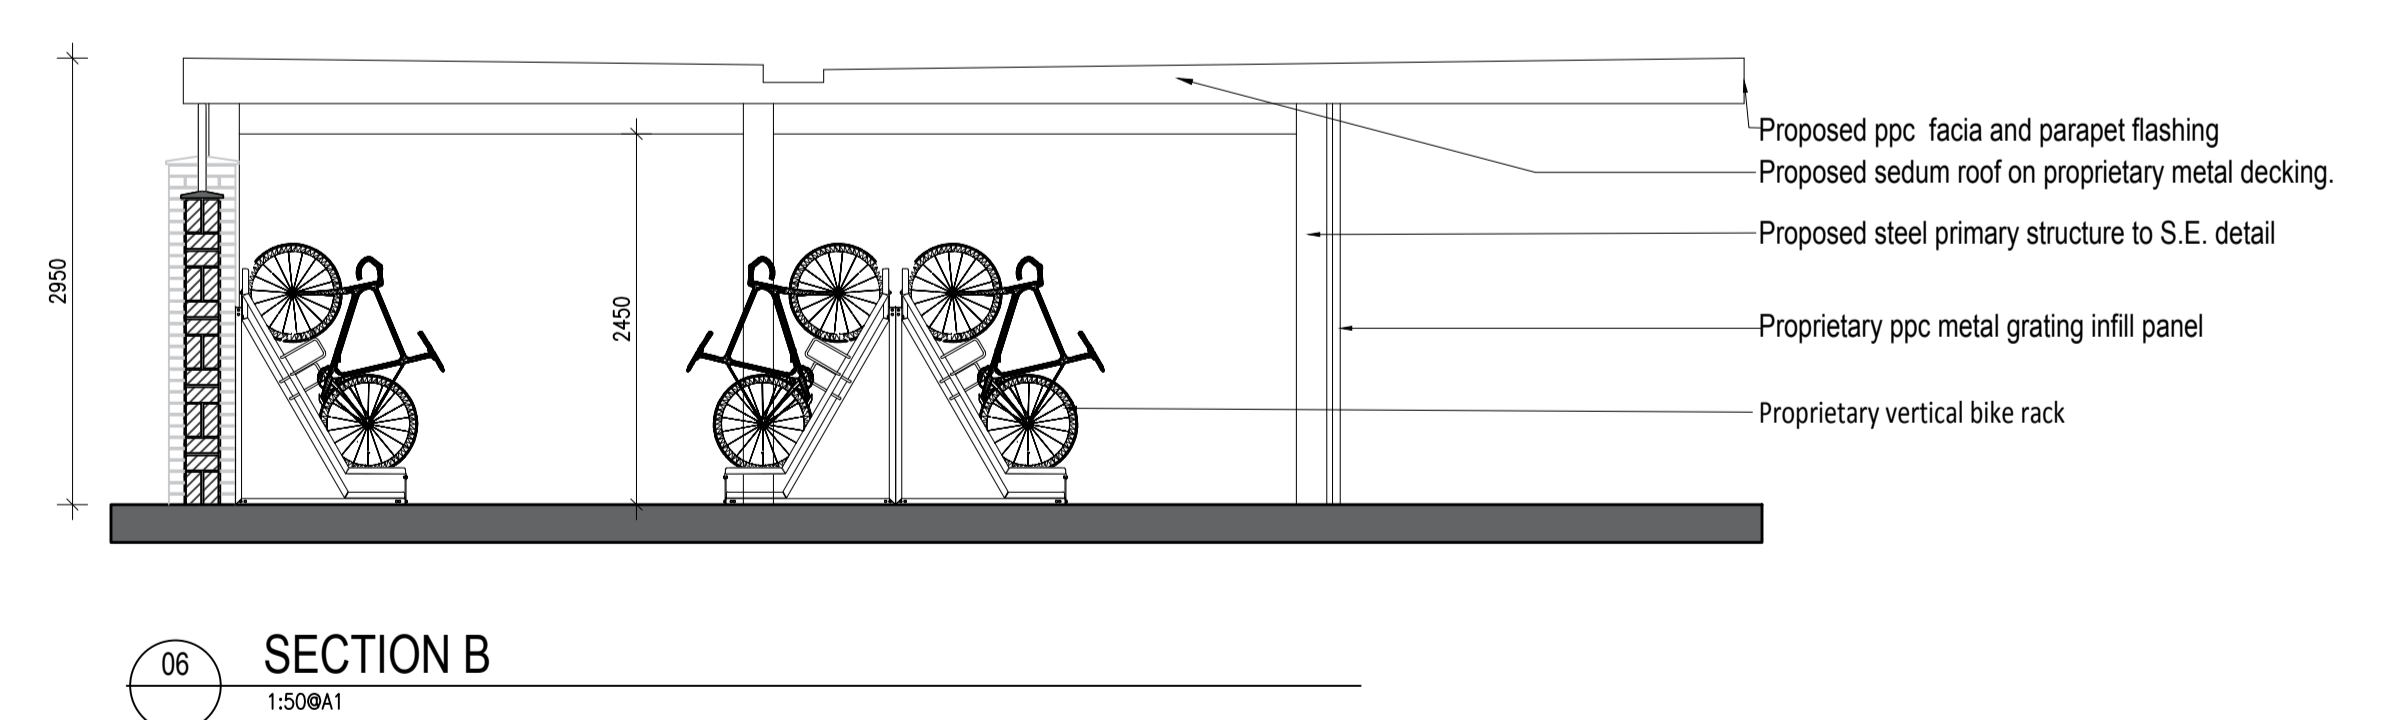
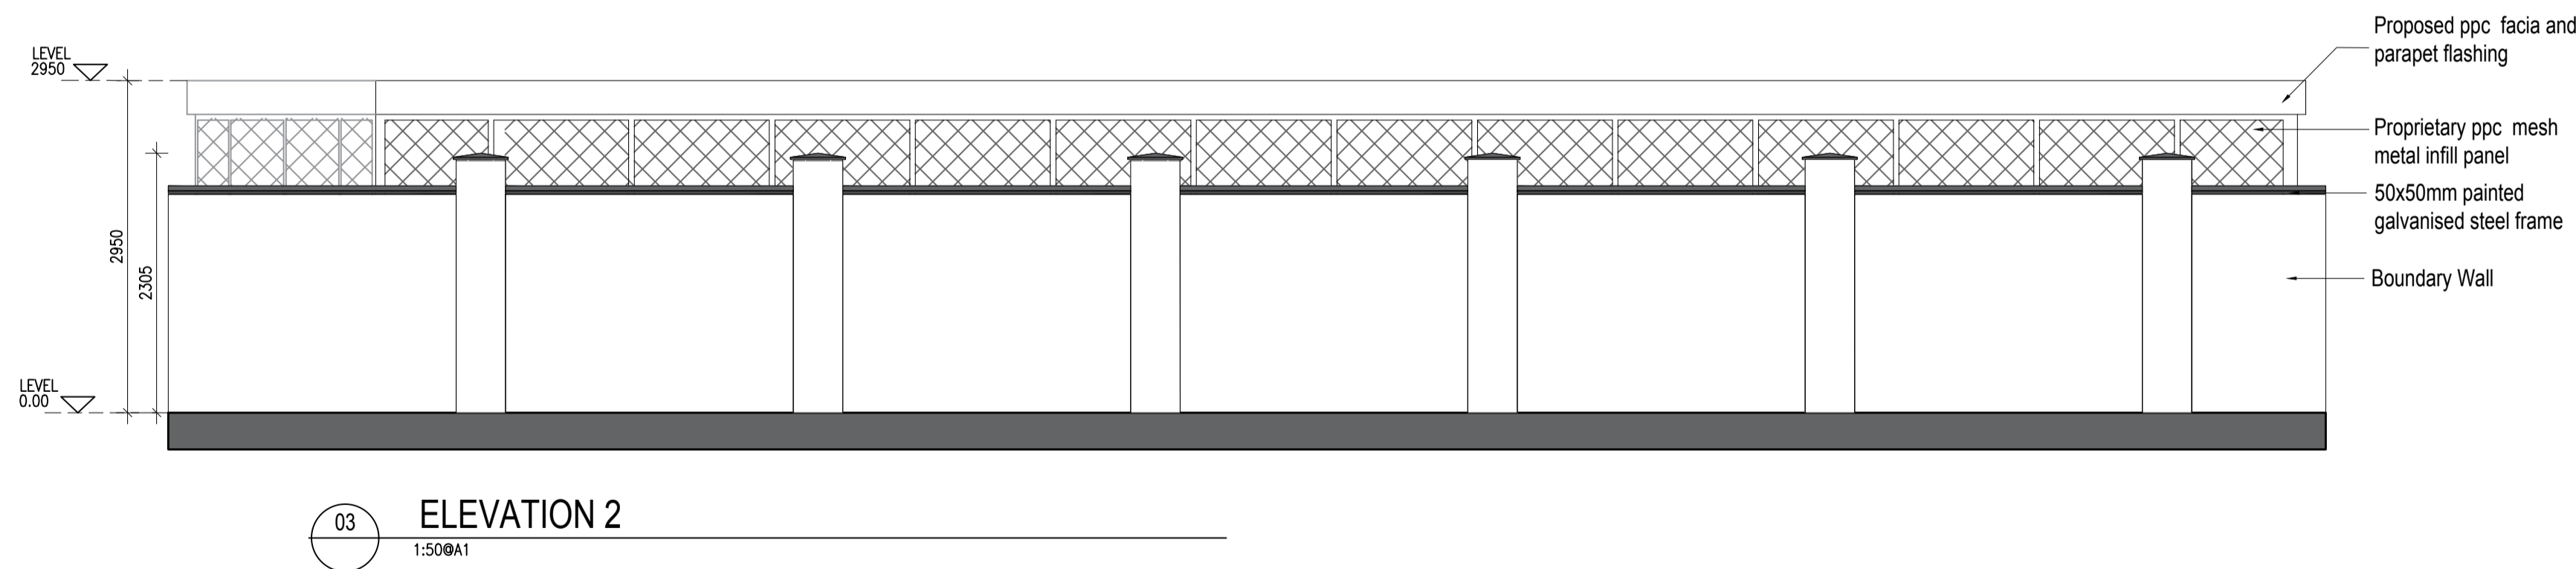
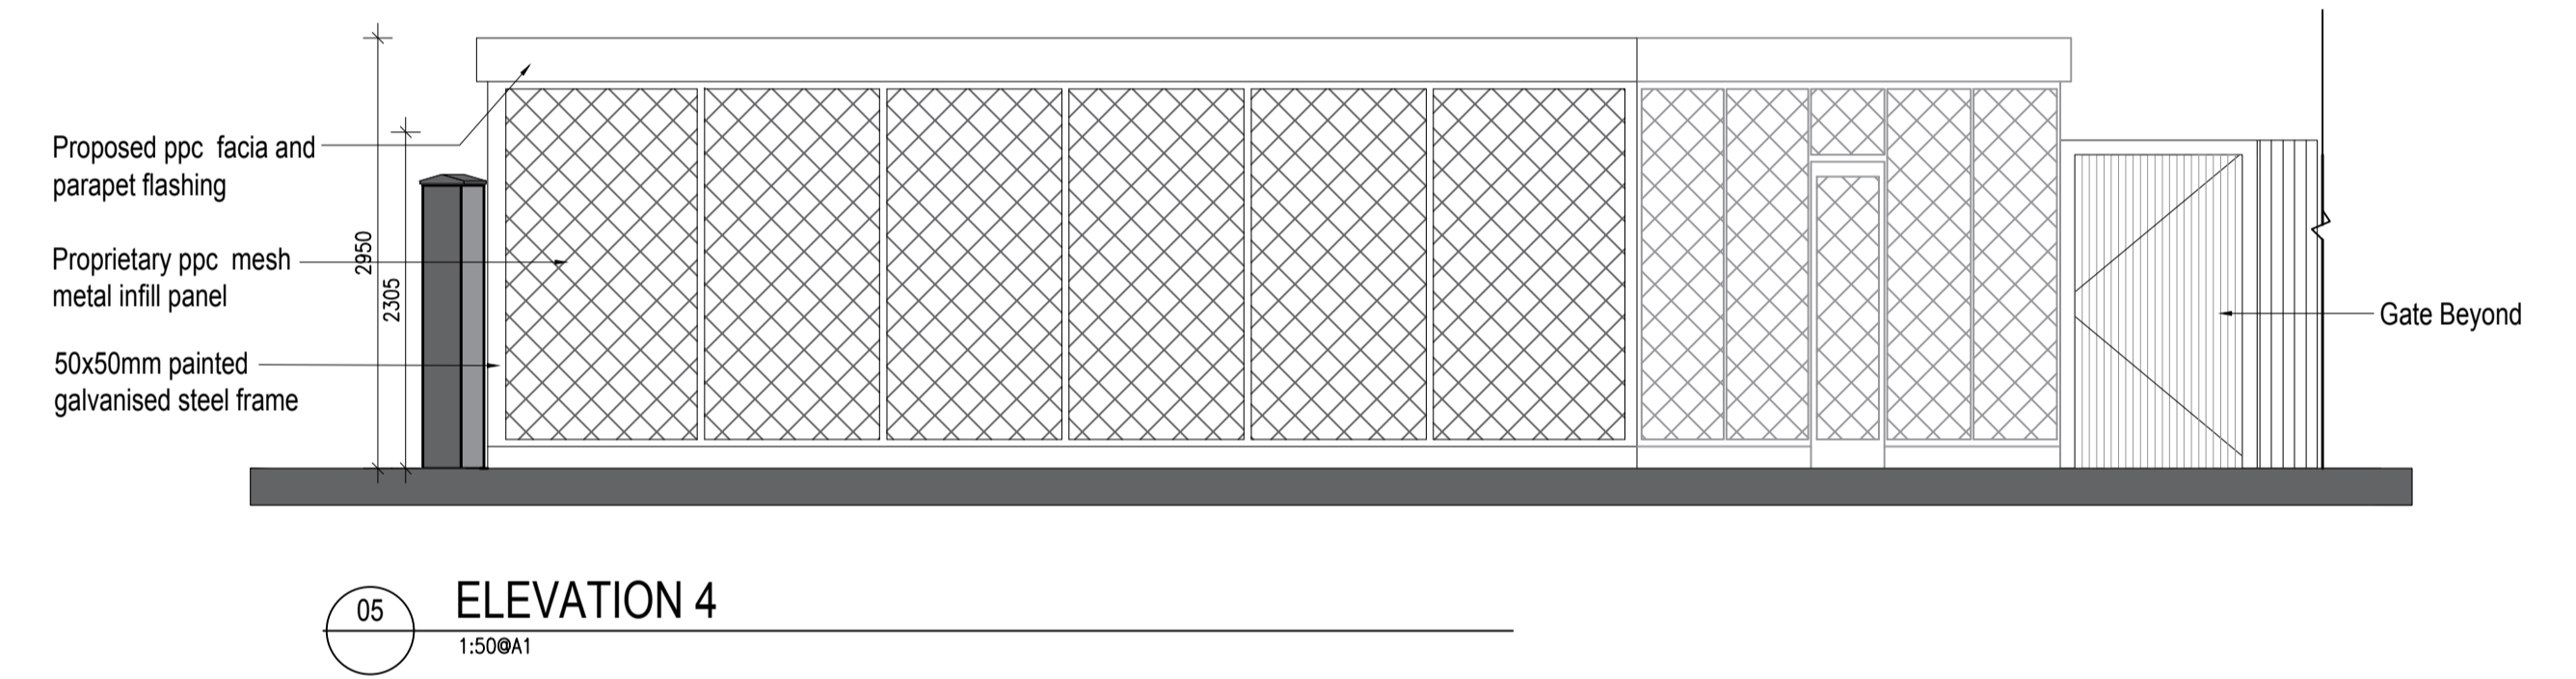
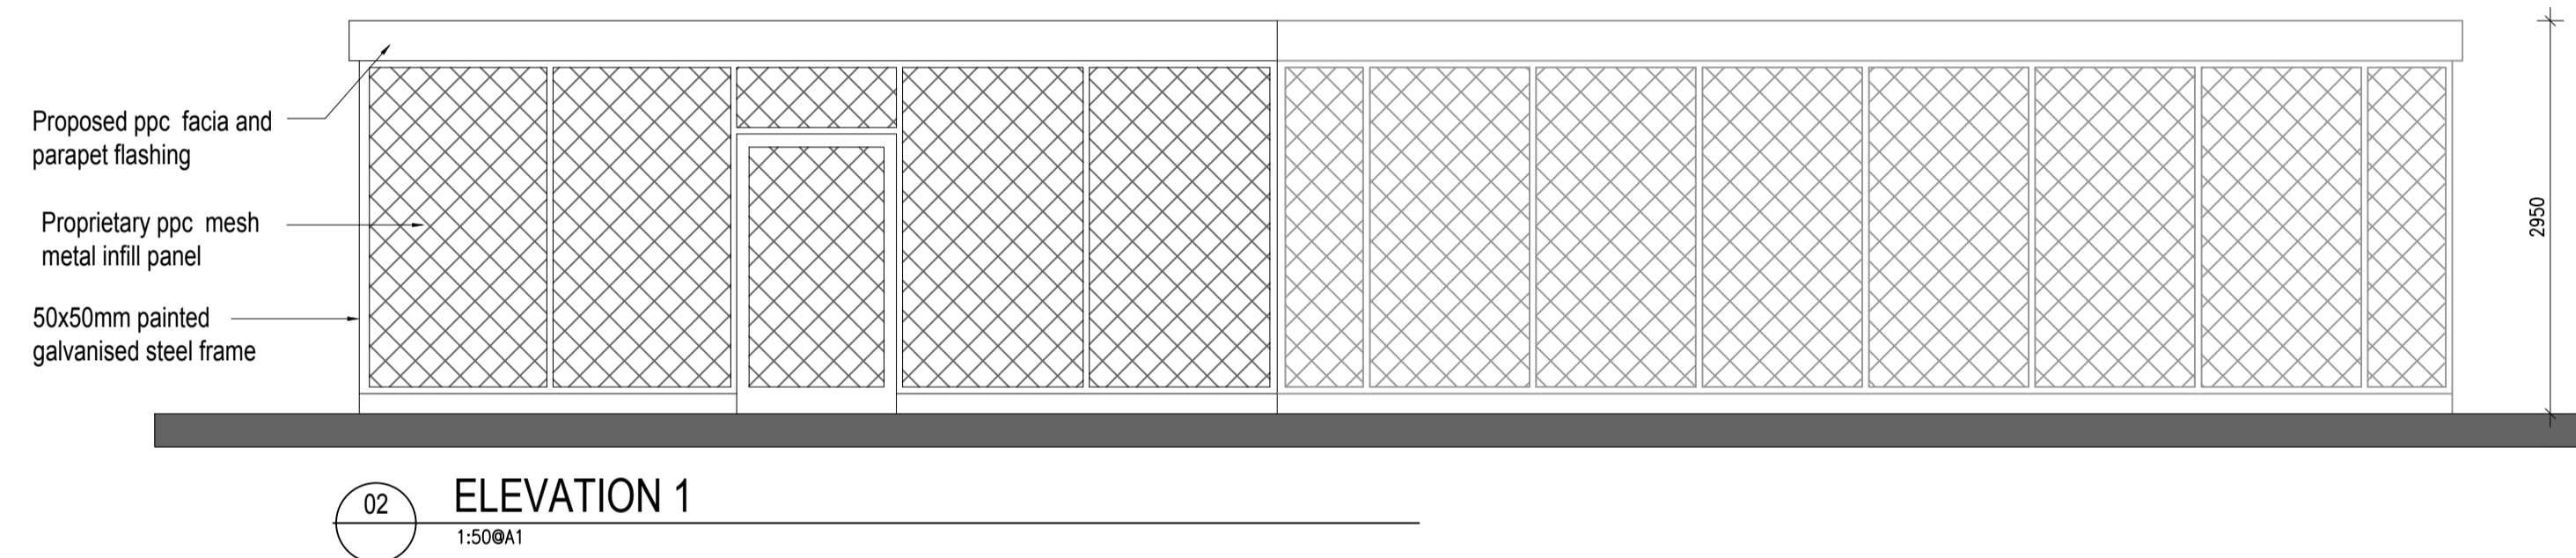
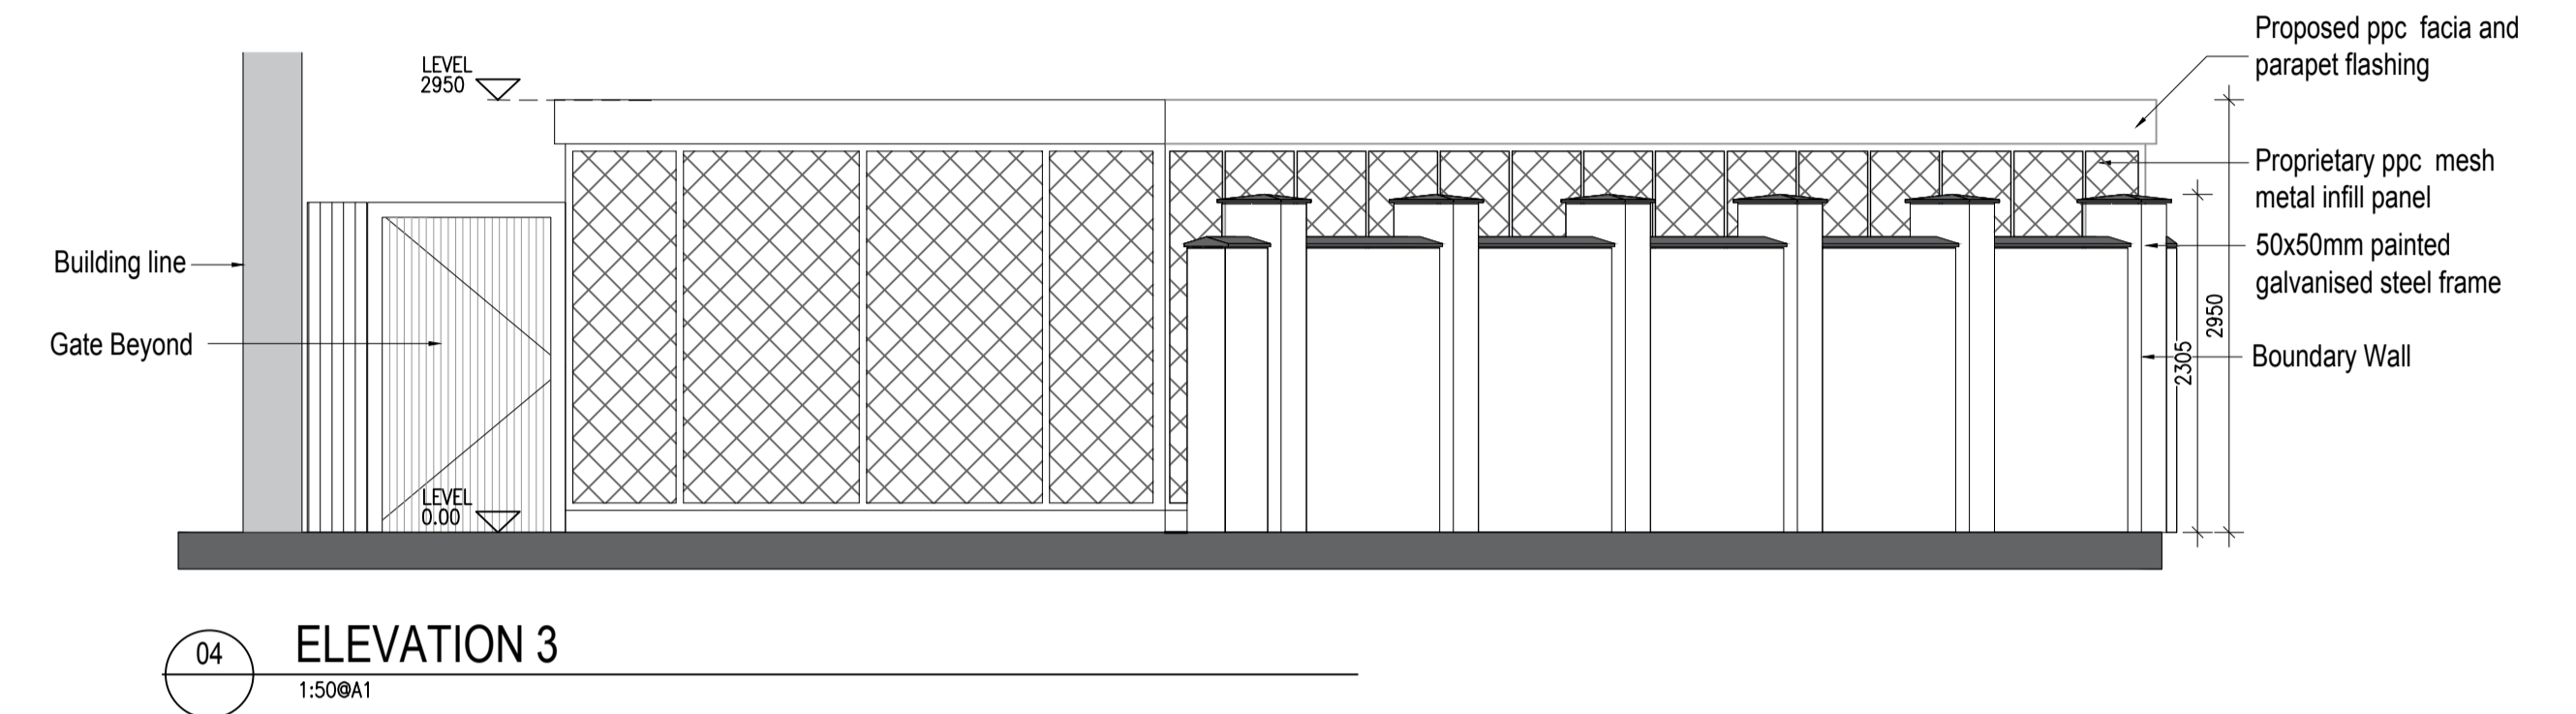


TYPE 2

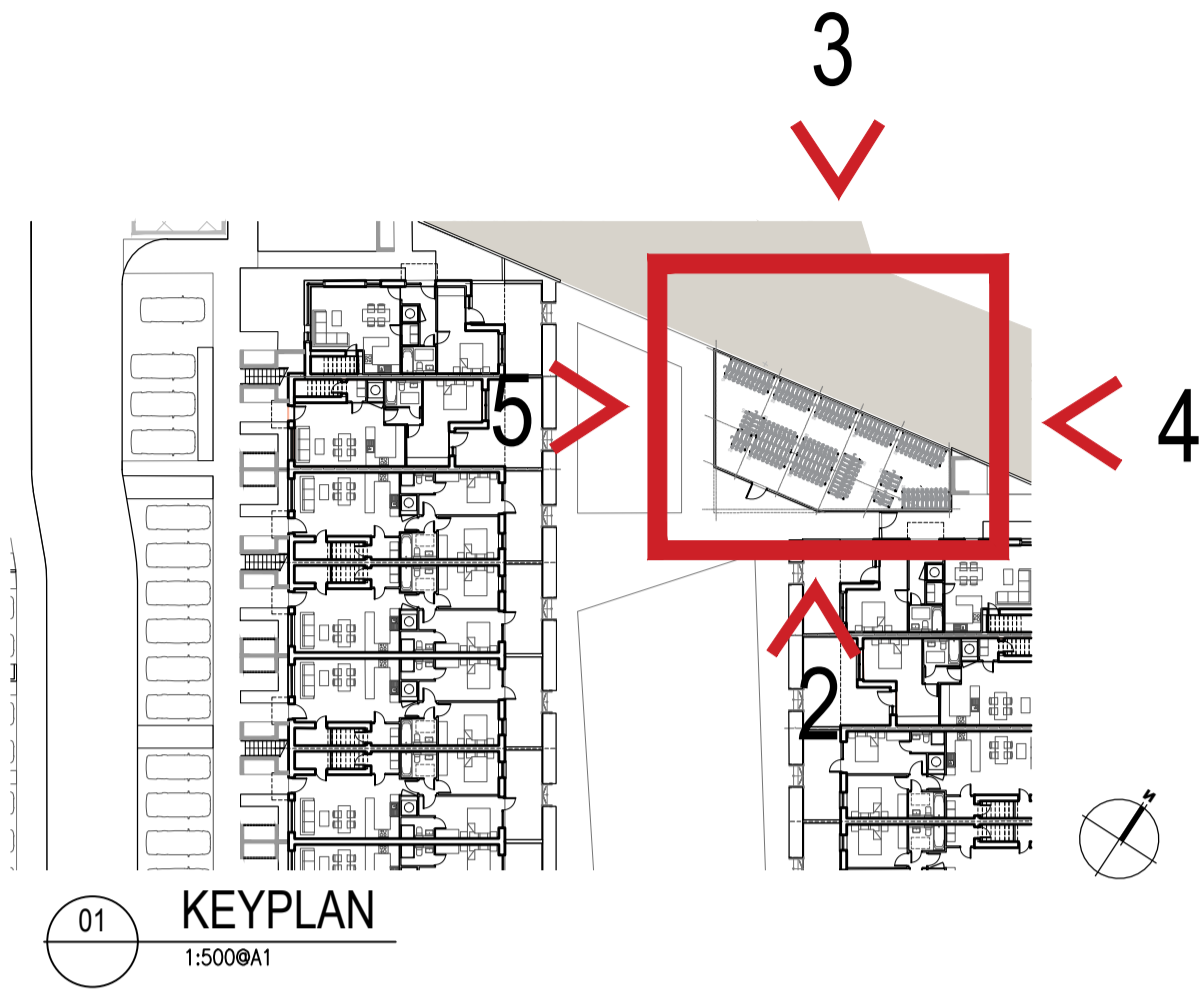

COVERED / SECURE BICYCLE STORE TYPE 2 - FOR DUPLEX UNITS

Notes	Issue Status
1. Copyright Reserved	Progress
2. Work to agreed dimensions only. Do not scale drawing	Planning Application
3. The contractor is responsible for checking all levels and dimensions on site and shall refer all discrepancies to the Architect	Fire Cert
4. Where appropriate, for details of r.c. structure, or mechanical and electrical details, see Engineers drawings	Disability Cert
5. Proprietary items shall be fixed in strict accordance with manufacturers instructions.	Tender
6. Sizes of proprietary items shall be checked with manufacturer.	Construction
7. The contractor shall be responsible for the coordination of structure, finishes and services.	As Built
	Information Only

No.	Date	Revision	Initials
01	30.03.2020	SHD Planning Application	SK

Project	Steeles Road, Duleek Residential Development
Drawing Title	Bicycle Store Type 2 Details Sheet 2 of 2
Drawing No	6204-P-402
Scale	as shown@A1
Rev	01
Drawn	SR
Date	MAR / 2020

6-7 HARROUPT TERRACE, DUBLIN 2, IRELAND
t +353-1-8782400 f +353-1-8787395
www.bkd.ie

bkdarchitects
BURKE-KENNEDY DOYLE