




1 BIN STORE TYPE 1 PLAN
1:20@A1

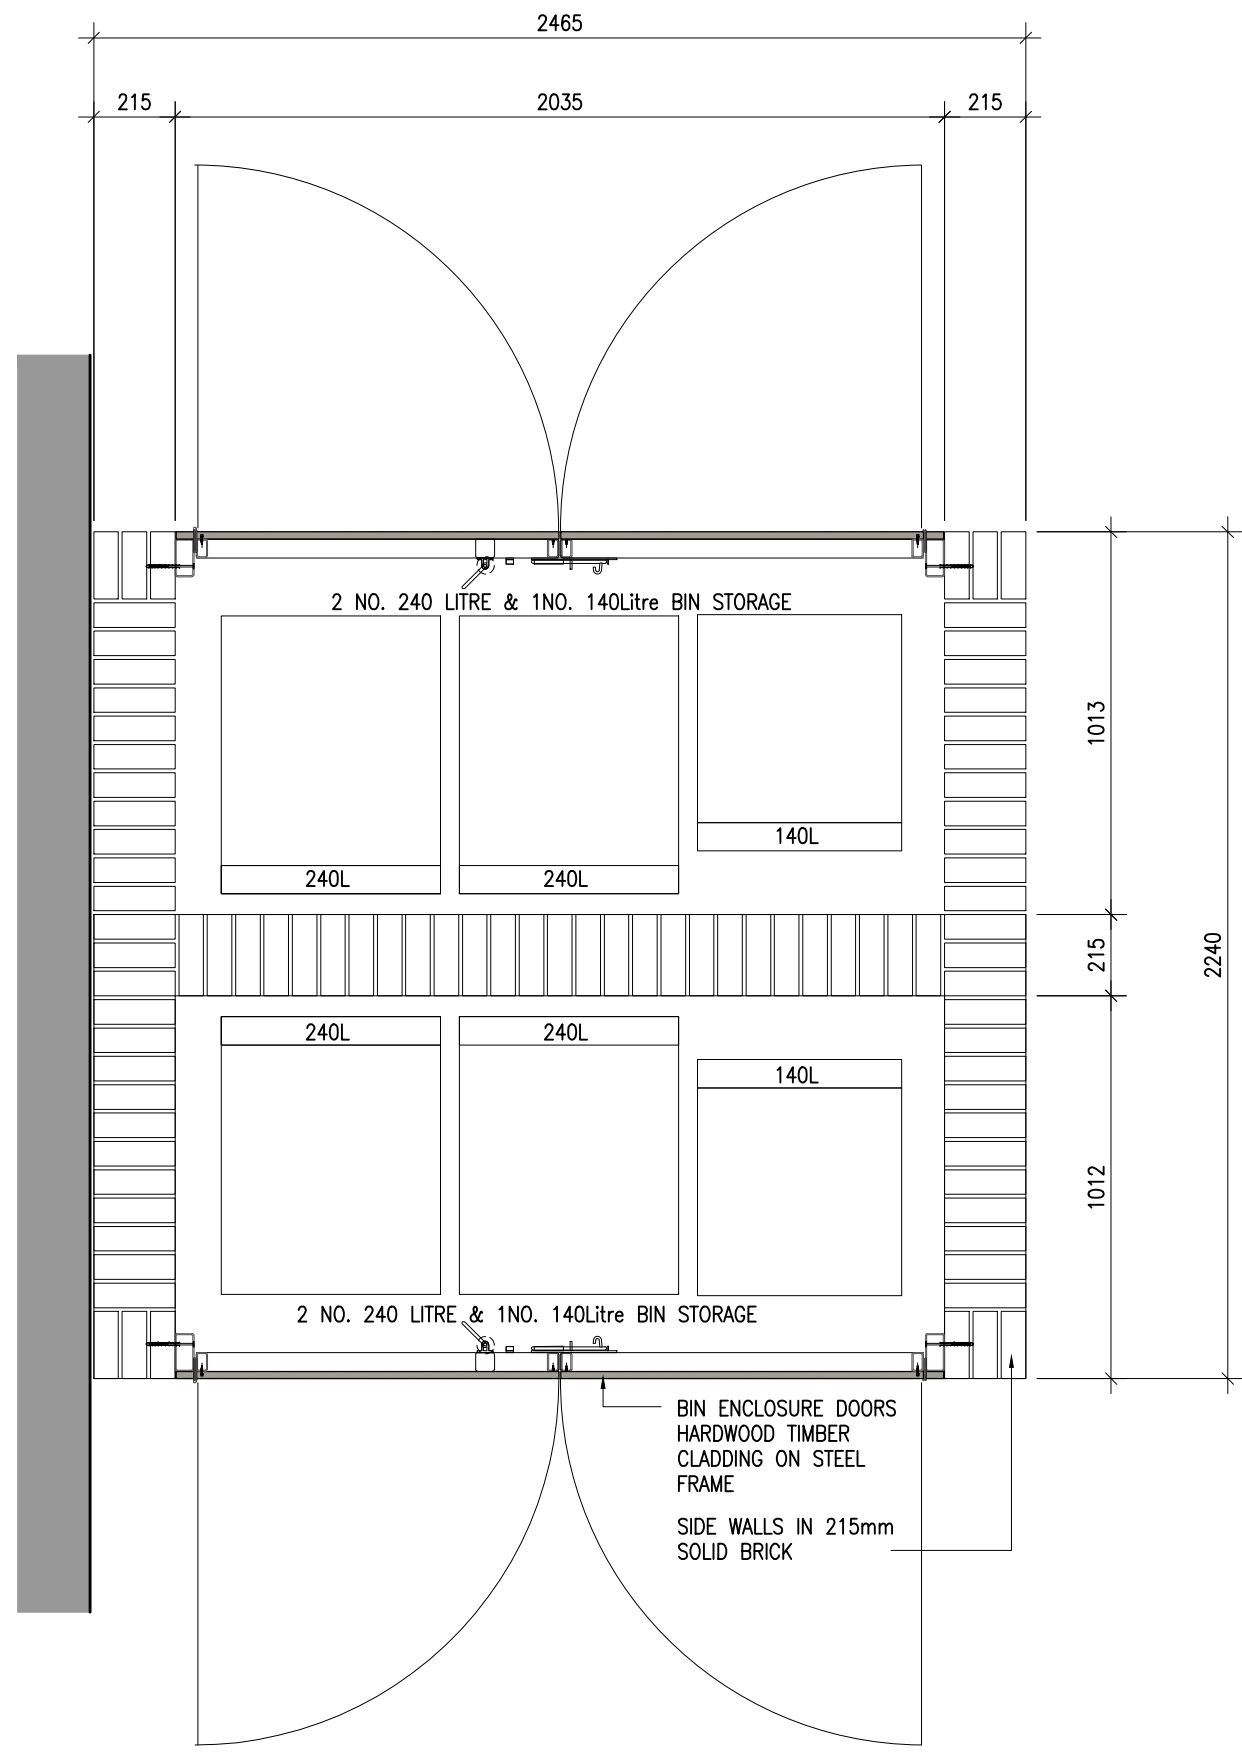


5 BIN STORE TYPE 2 PLAN
1:20@A1

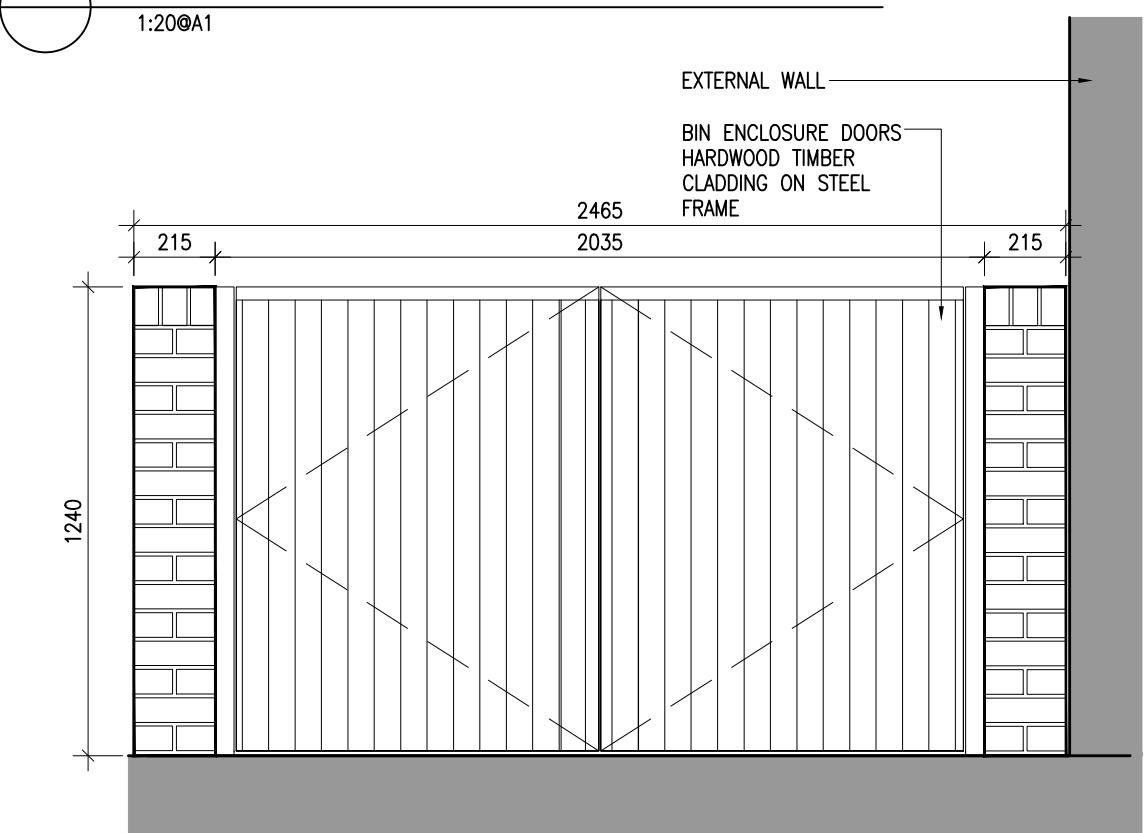


2 BIN STORE TYPE 1 FRONT ELEVATION
1:20@A1

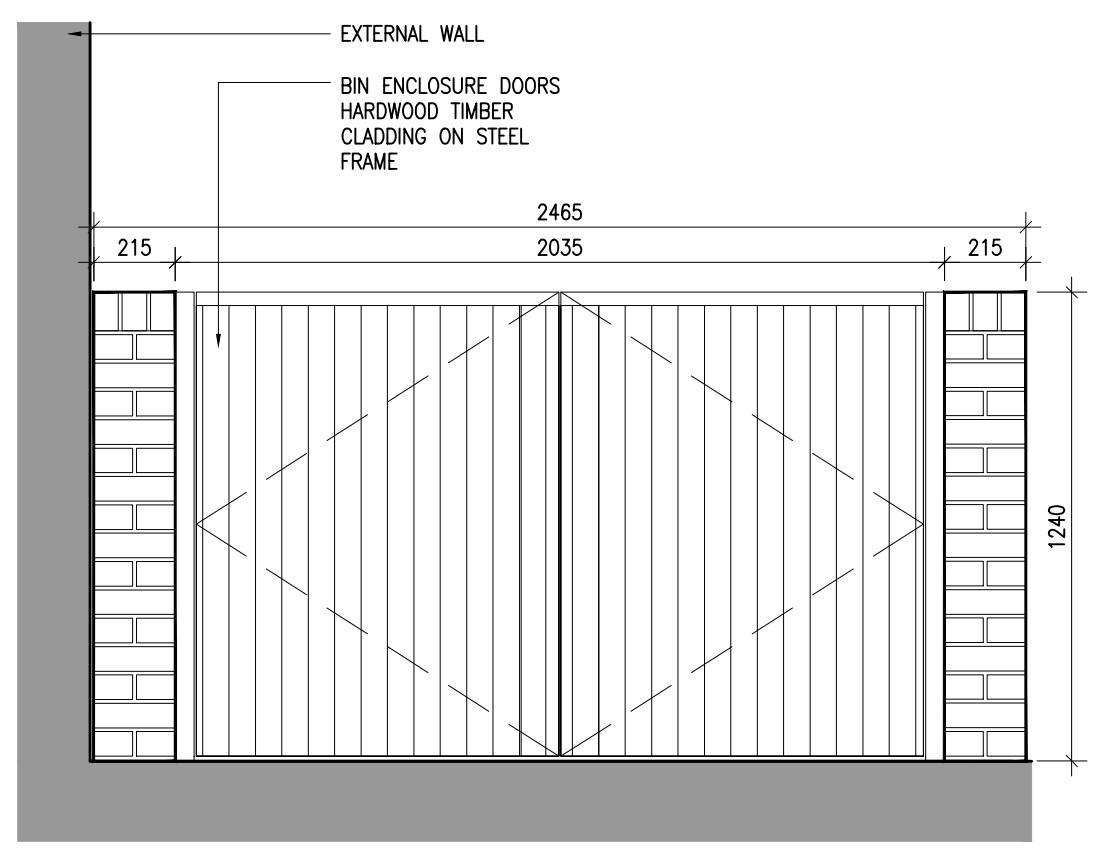


6 BIN STORE TYPE 2 FRONT ELEVATION
1:20@A1

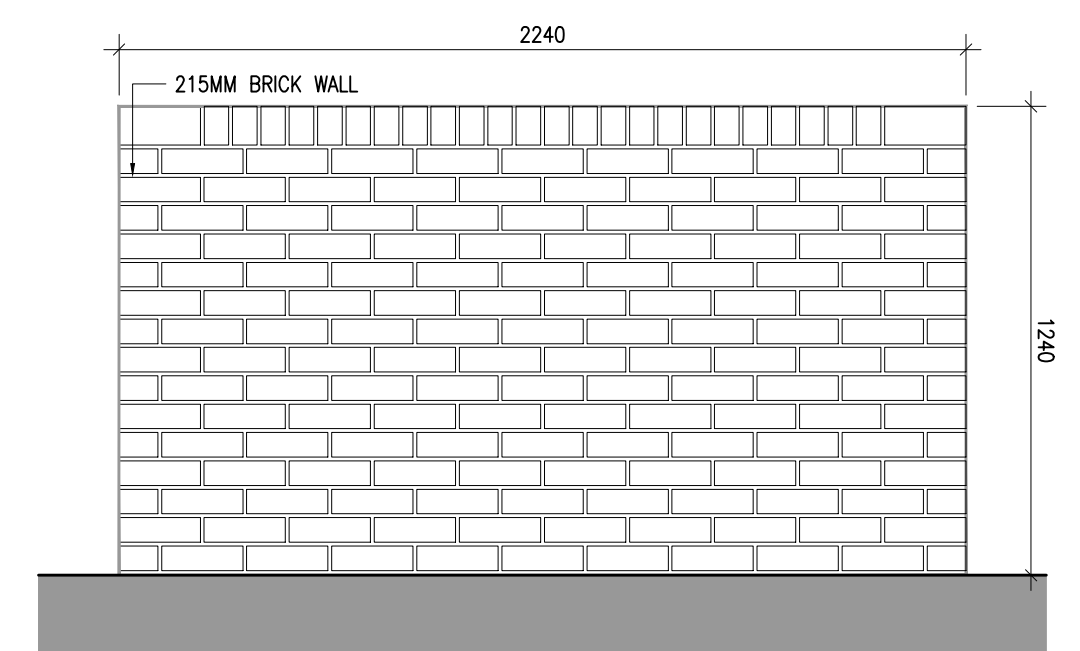

7 BIN STORE TYPE 2 SIDE ELEVATION
1:20@A1

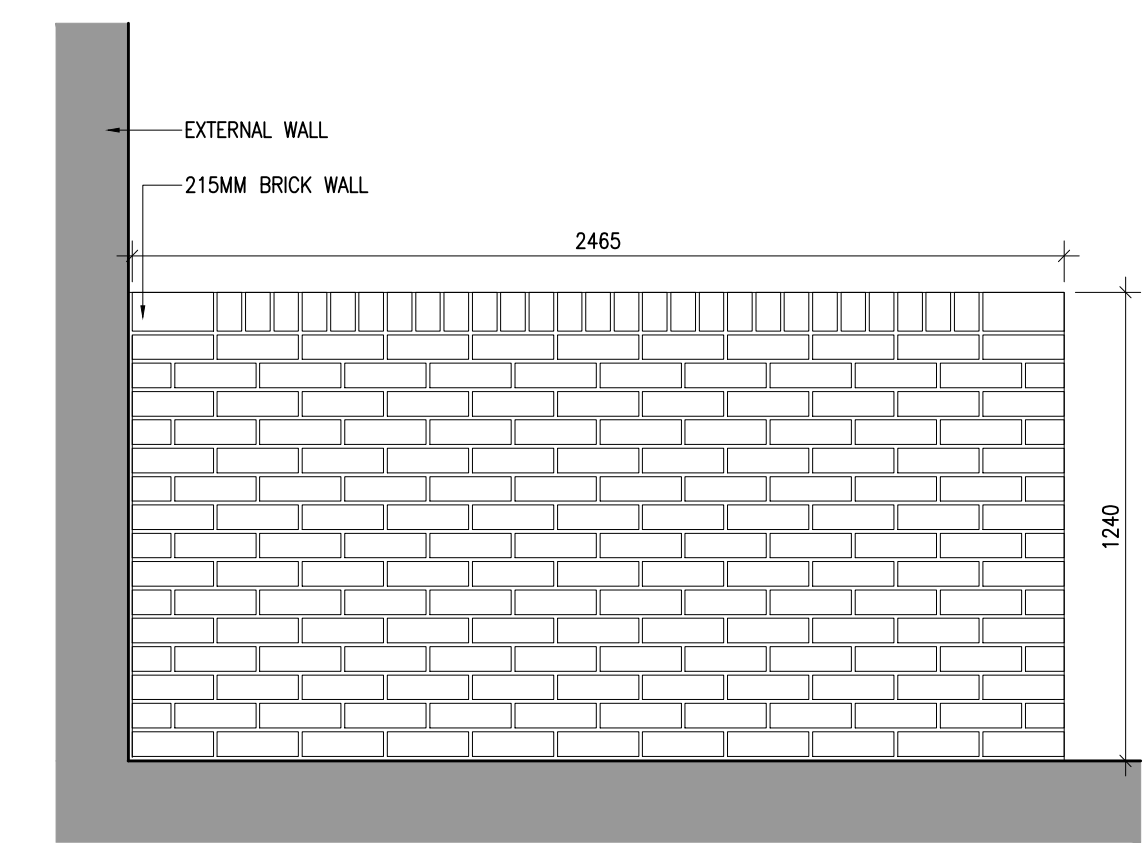

3 BIN STORE TYPE 1 REAR ELEVATION
1:20@A1

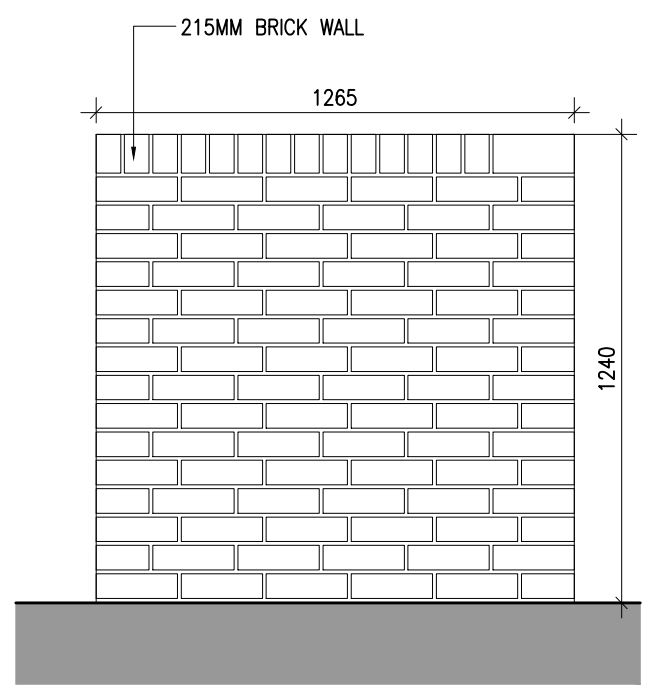

4 BIN STORE TYPE 1 SIDE ELEVATION
1:20@A1

BIN STORE TYPE 1 & 2

Notes	Issue Status
1. Copyright Reserved	Progress
2. Work to signed dimensions only. Do not scale drawing.	Planning Application
3. The contractor is responsible for checking all levels and dimensions on site and shall refer all discrepancies to the Architect	Fire Cert
4. Where appropriate, for details of r.c. structure, or mechanical and electrical details, see Engineers drawings	Disability Cert
5. Proprietary items shall be fixed in strict accordance with manufacturers instructions.	Tender
6. Sizes of proprietary items shall be checked with manufacturer.	Construction
7. The contractor shall be responsible for the coordination of structure, finishes and services.	As Built
	Information Only

No.	Date	Revision	Initials
01	30.03.2020	SHD Planning Application	SK

Project	Steeple Road, Duleek, Co. Meath Residential Development	6-7 HARPCOURT TERRACE, DUBLIN 2, IRELAND T: +353-1-8782400 F: +353-1-8787395 www.bkd.ie			
Drawing Title	Bin Store Type 1 & 2 - Details				
Drawing No	6204 - P - 404				
Scale	1:20@A1				
Rev	01	Drawn	SR	Date	March'20